



EXISTING KEY PLAN

A0.1


THIS IS A CUSTOM BASIC FLOOR PLAN:  
MAJOR STRUCTURAL ELEMENTS ONLY  
PLUS PLUMBING FIXTURES.

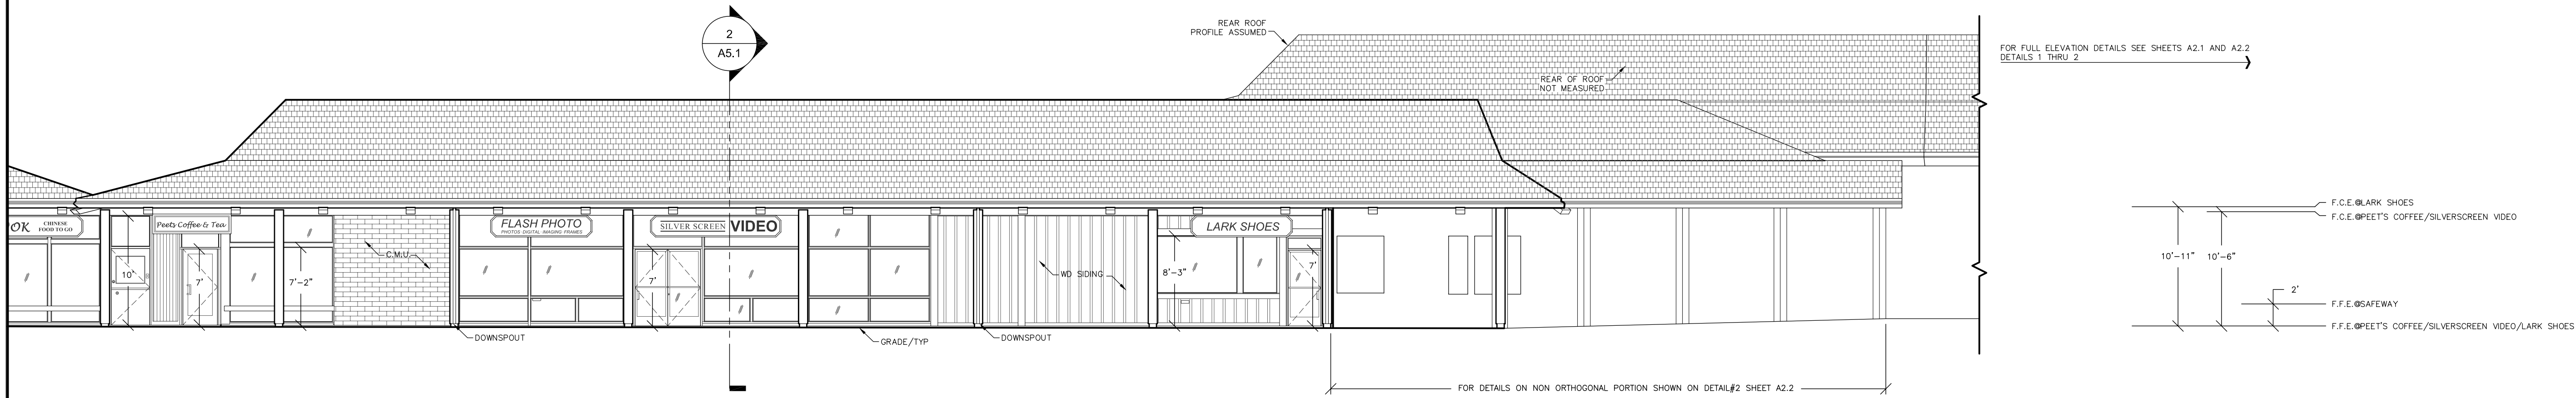

3 EXISTING PARTIAL NORTH EAST ELEVATION  
SCALE : 1/8"=1'-0"

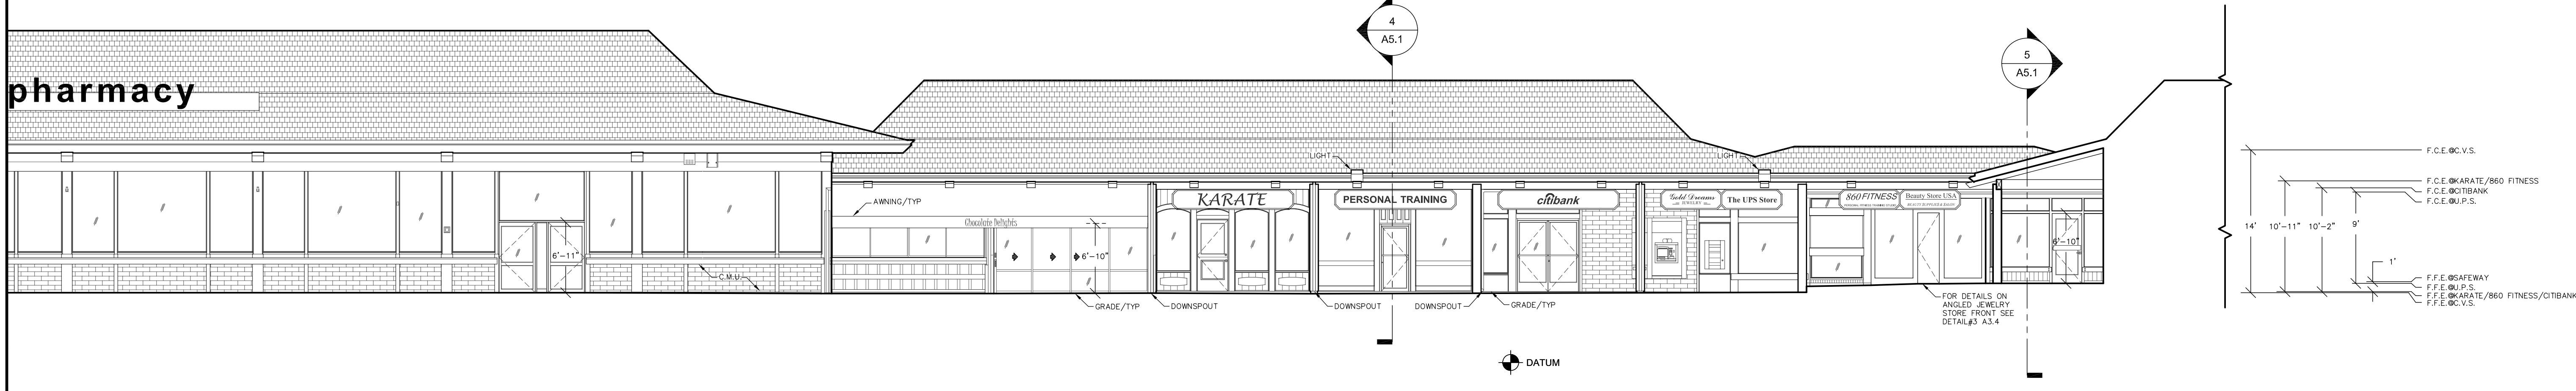


2 EXISTING PARTIAL NORTH ELEVATION  
SCALE : 1/8"=1'-0"

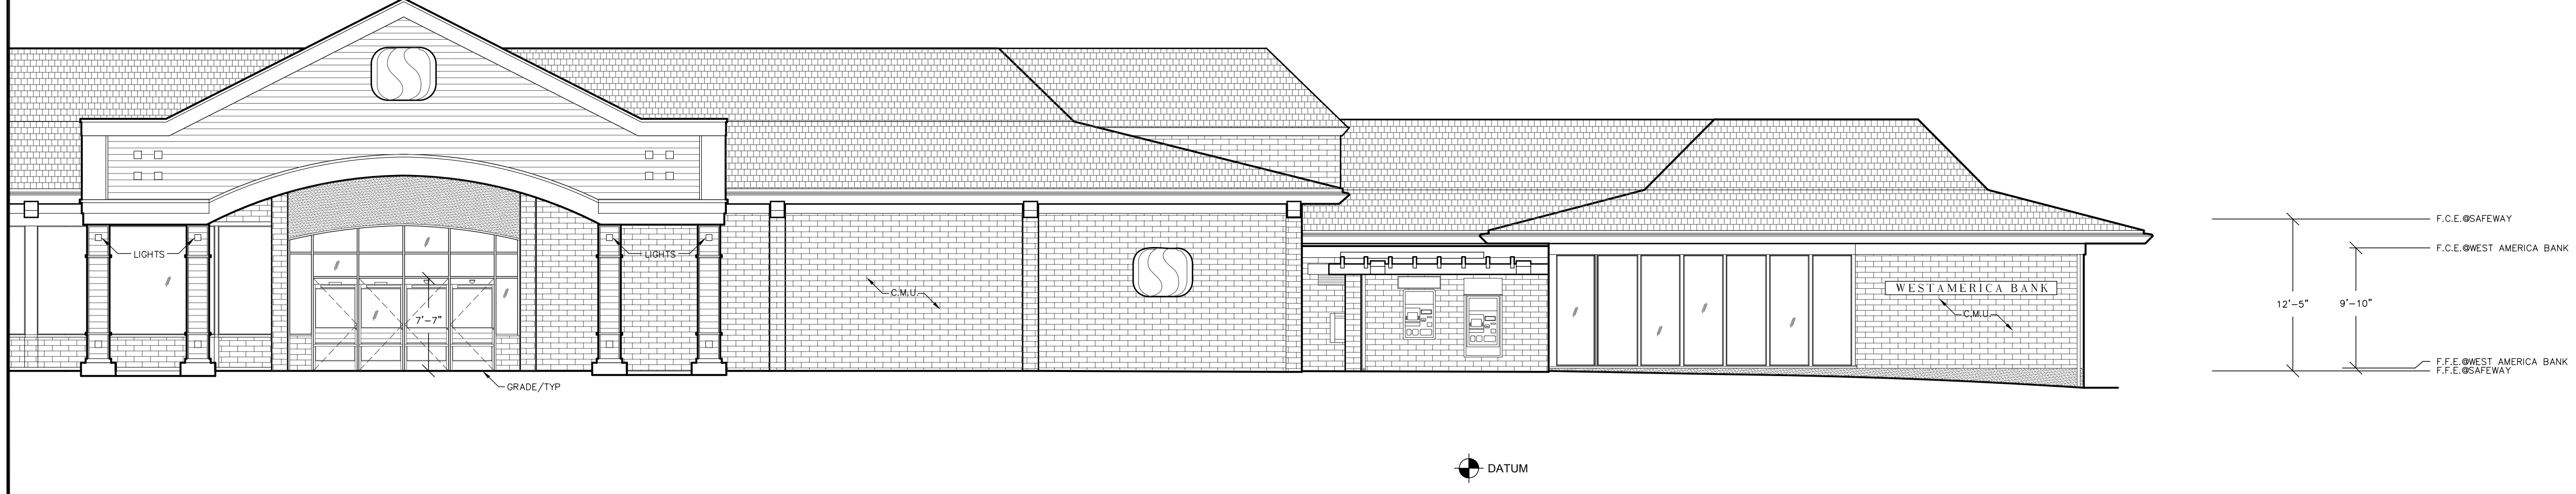

1 EXISTING PARTIAL EAST ELEVATION  
SCALE : 1/8"=1'-0"


EXISTING EXTERIOR ELEVATIONS

F.C.E. @ REDHILL CAKE & PASTRY  
 F.C.E. @ REDHILL PET CENTER / HOT WOK / PEETS COFFEE  
 F.C.E. @ BURRITVILLE  
 F.C.E. @ PRECISION 6 HAIRCUTS  
 9'-11" 10'-1" 10'-6" 11'-6"  
 F.F.E. @ SAFEWAY  
 F.F.E. @ BURRITVILLE  
 F.F.E. @ REDHILL PET CENTER  
 F.F.E. @ SILVERSCREEN VIDEO / PRECISION 6 / HOT WOK / PEETS COFFEE  
 F.F.E. @ REDHILL CAKE & PASTRY  
 2'-6"

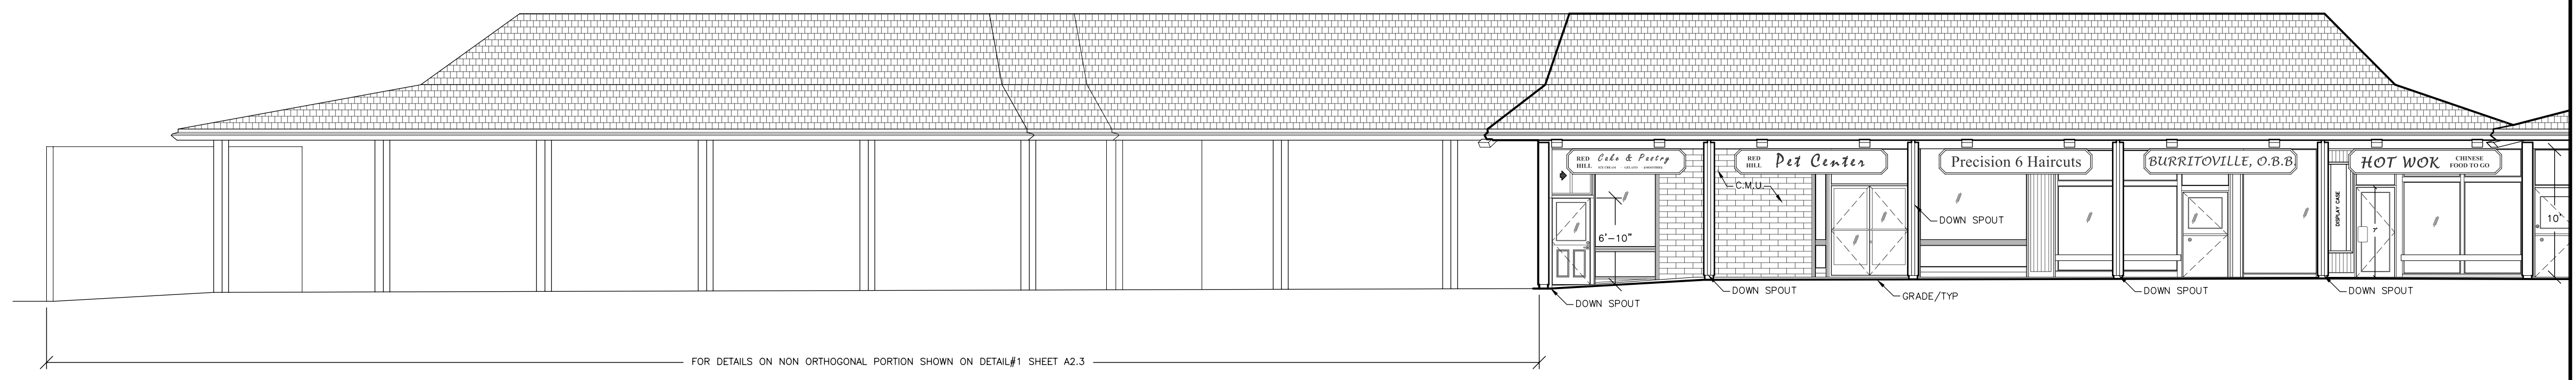


3 EXISTING PARTIAL NORTH EAST ELEVATION  
 SCALE : 1/8"=1'-0"

FOR FULL ELEVATION DETAILS SEE SHEETS A2.1 AND A2.2 DETAILS 3 & SHEET A2.3 DETAIL #1  
 F.F.E. @ EASY STREET CAFE  
 10'-1"  
 F.F.E. @ SAFEWAY  
 2'-1"  
 F.F.E. @ EASY STREET CAFE

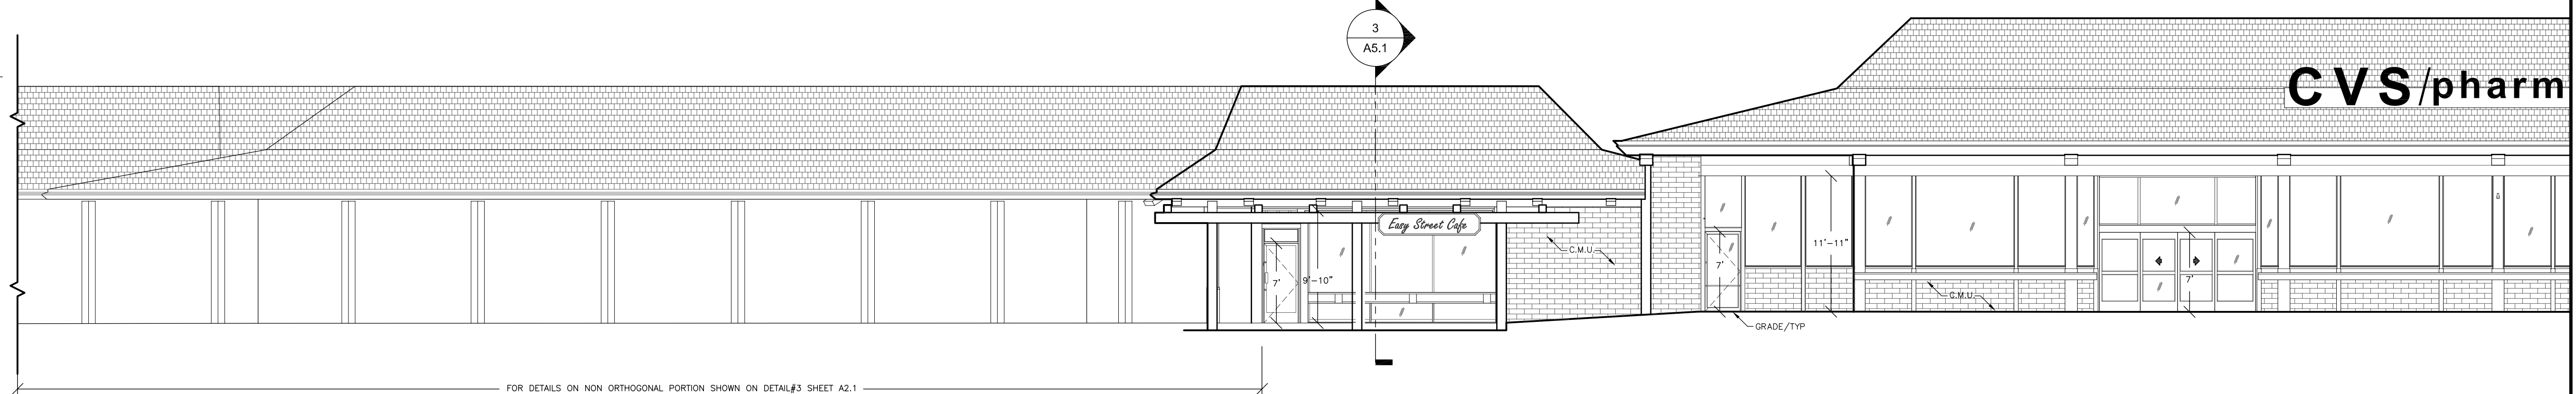


2 EXISTING PARTIAL EAST ELEVATION  
 SCALE : 1/8"=1'-0"

F.C.E. @ BEAUTY STORE USA / STELLAS FINE CONSIGNMENT  
 F.C.E. @ BRADLEY'S REAL ESTATE  
 F.C.E. @ BLUE NAILS  
 9'-2" 9'-5" 9'-4" 9'-7"  
 F.F.E. @ SAFEWAY / BEAUTY STORE USA / BRADLEY'S REAL ESTATE / STELLAS FINE CONSIGNMENT

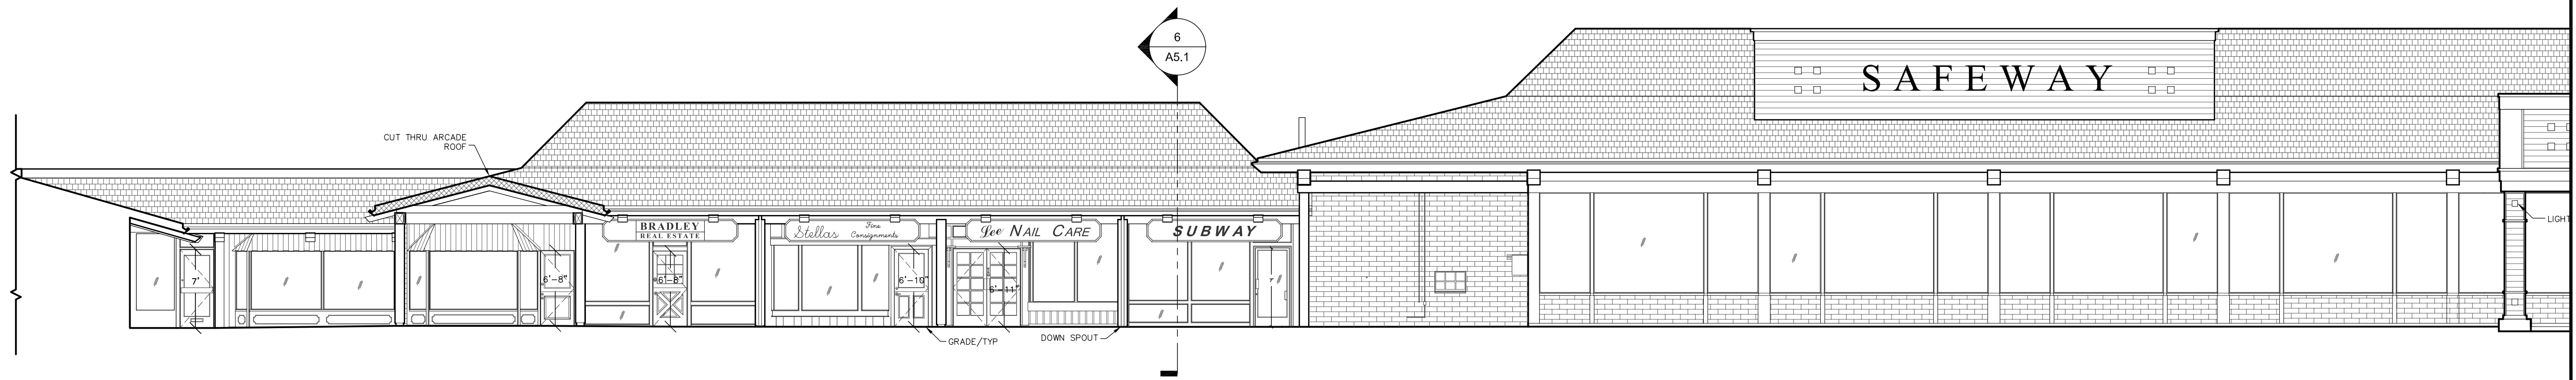


1 EXISTING PARTIAL EAST ELEVATION  
 SCALE : 1/8"=1'-0"

EXISTING EXTERIOR ELEVATIONS

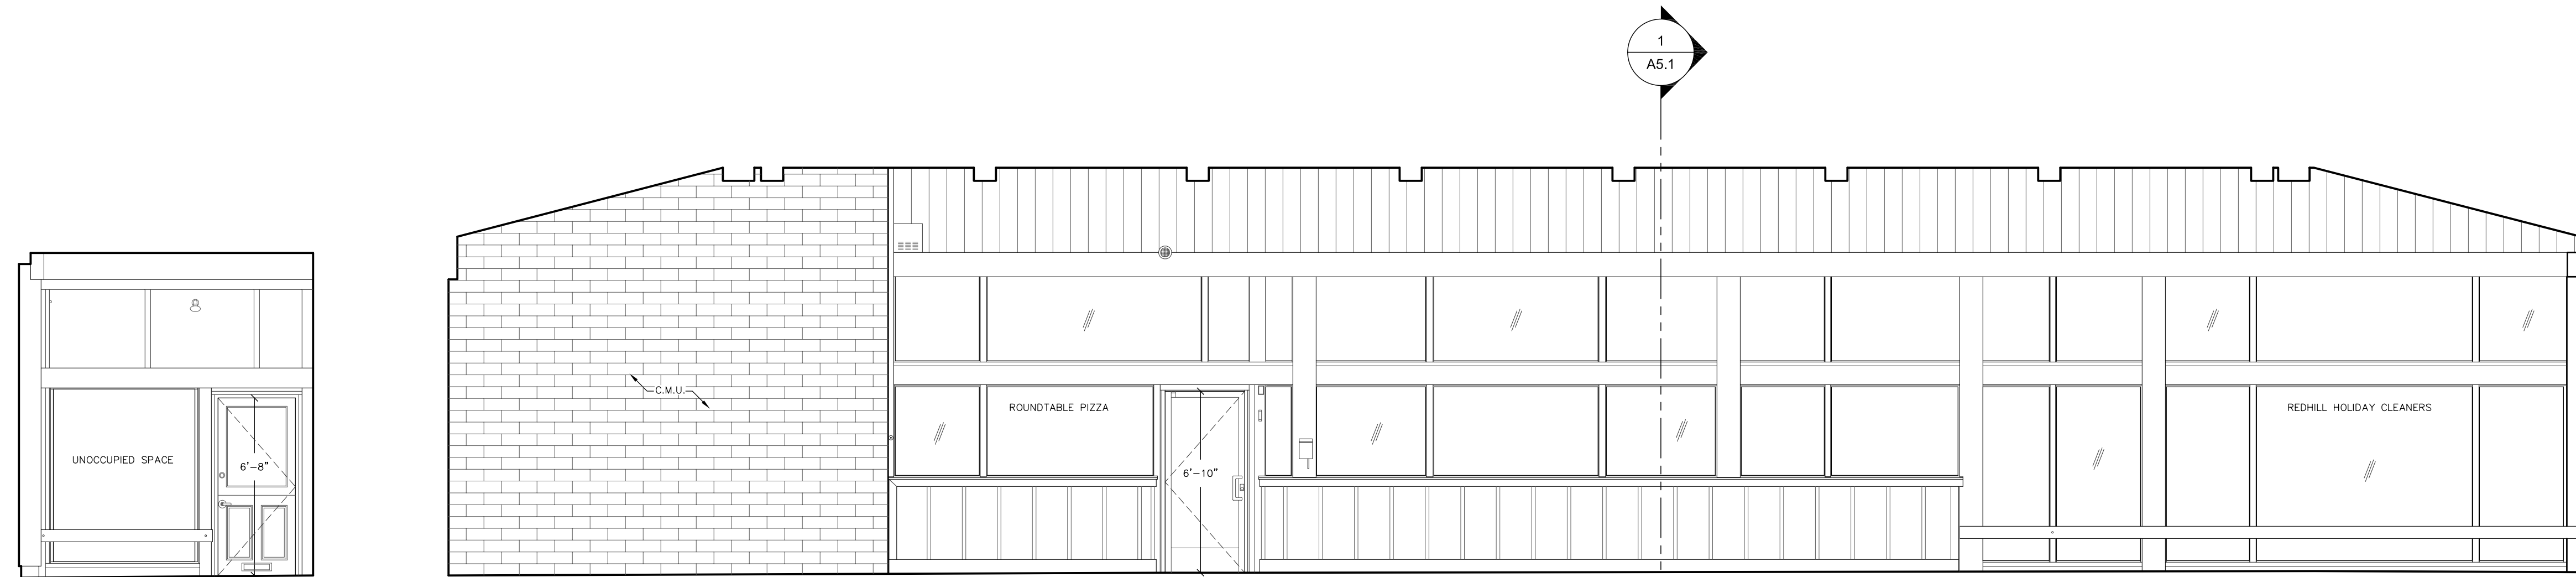


2 ARCADE ELEVATION  
SCALE : 1/4"=1'-0"

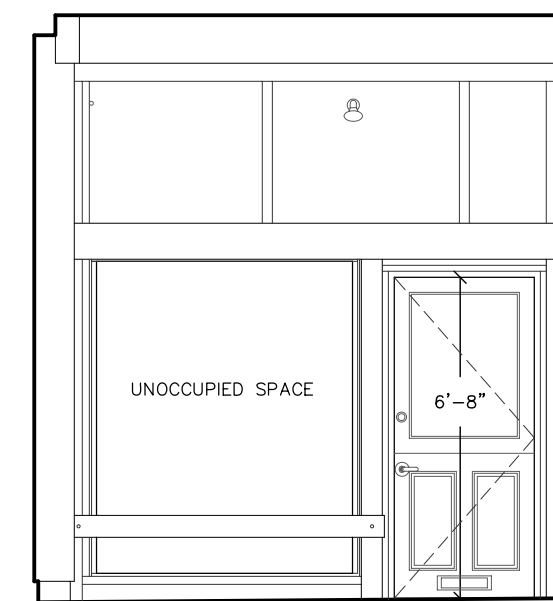

1 ARCADE ELEVATION  
SCALE : 1/4"=1'-0"




3 ARCADE ELEVATION  
SCALE : 1/4"=1'-0"

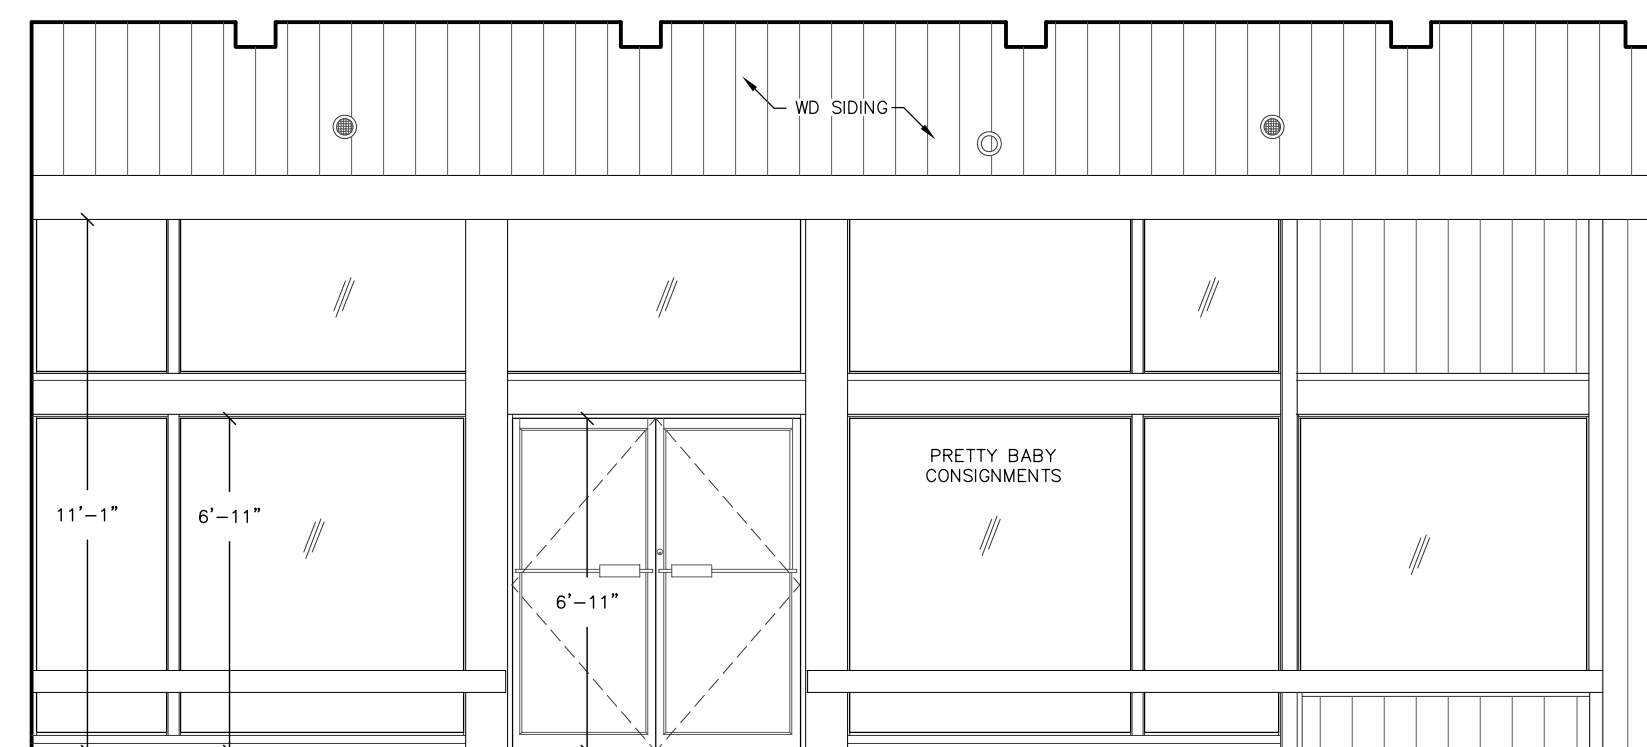


4 ARCADE ELEVATION  
SCALE : 1/4"=1'-0"



5 ARCADE ELEVATION  
SCALE : 1/4"=1'-0"

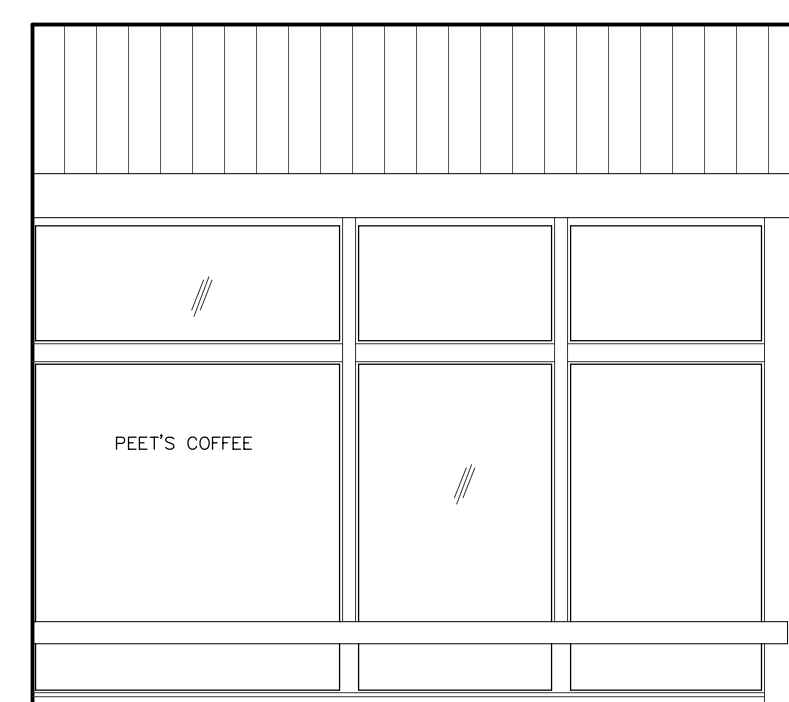

6 ARCADE ELEVATION  
SCALE : 1/4"=1'-0"

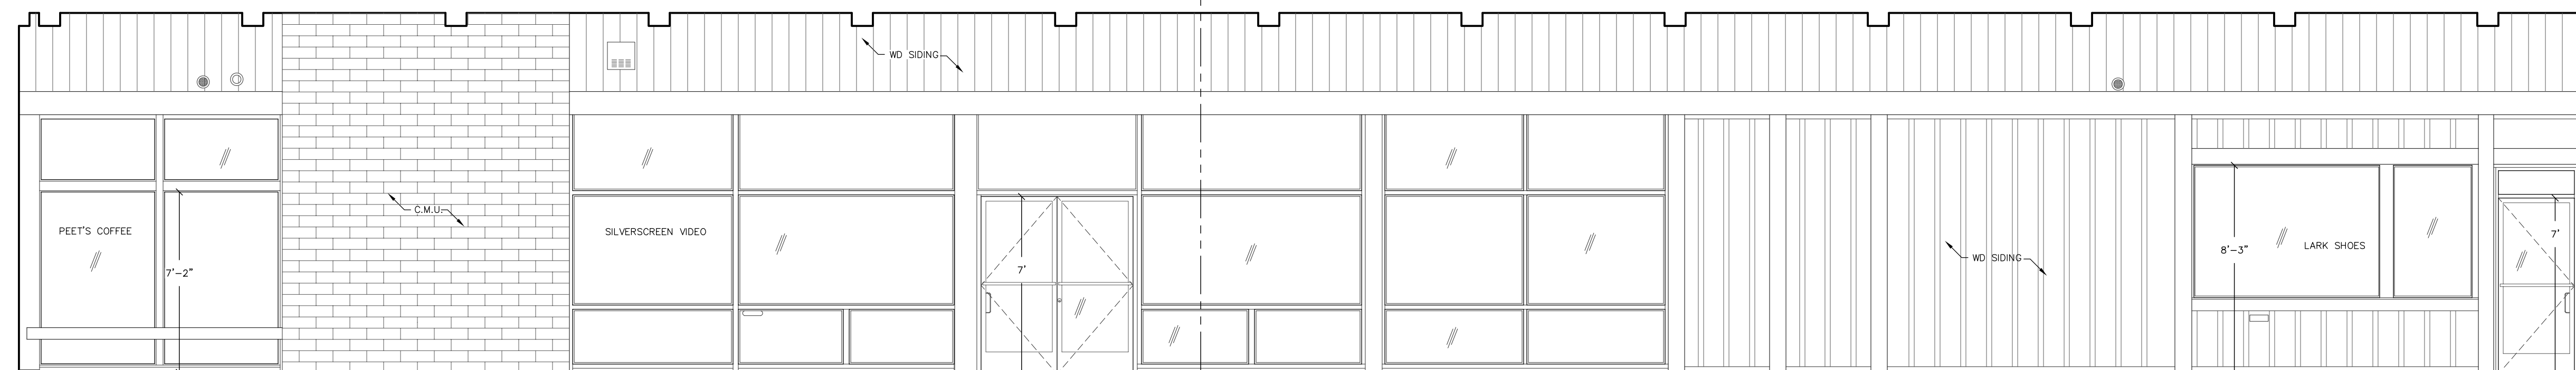

7 ARCADE ELEVATION  
SCALE : 1/4"=1'-0"

EXISTING ARCADE ELEVATIONS